
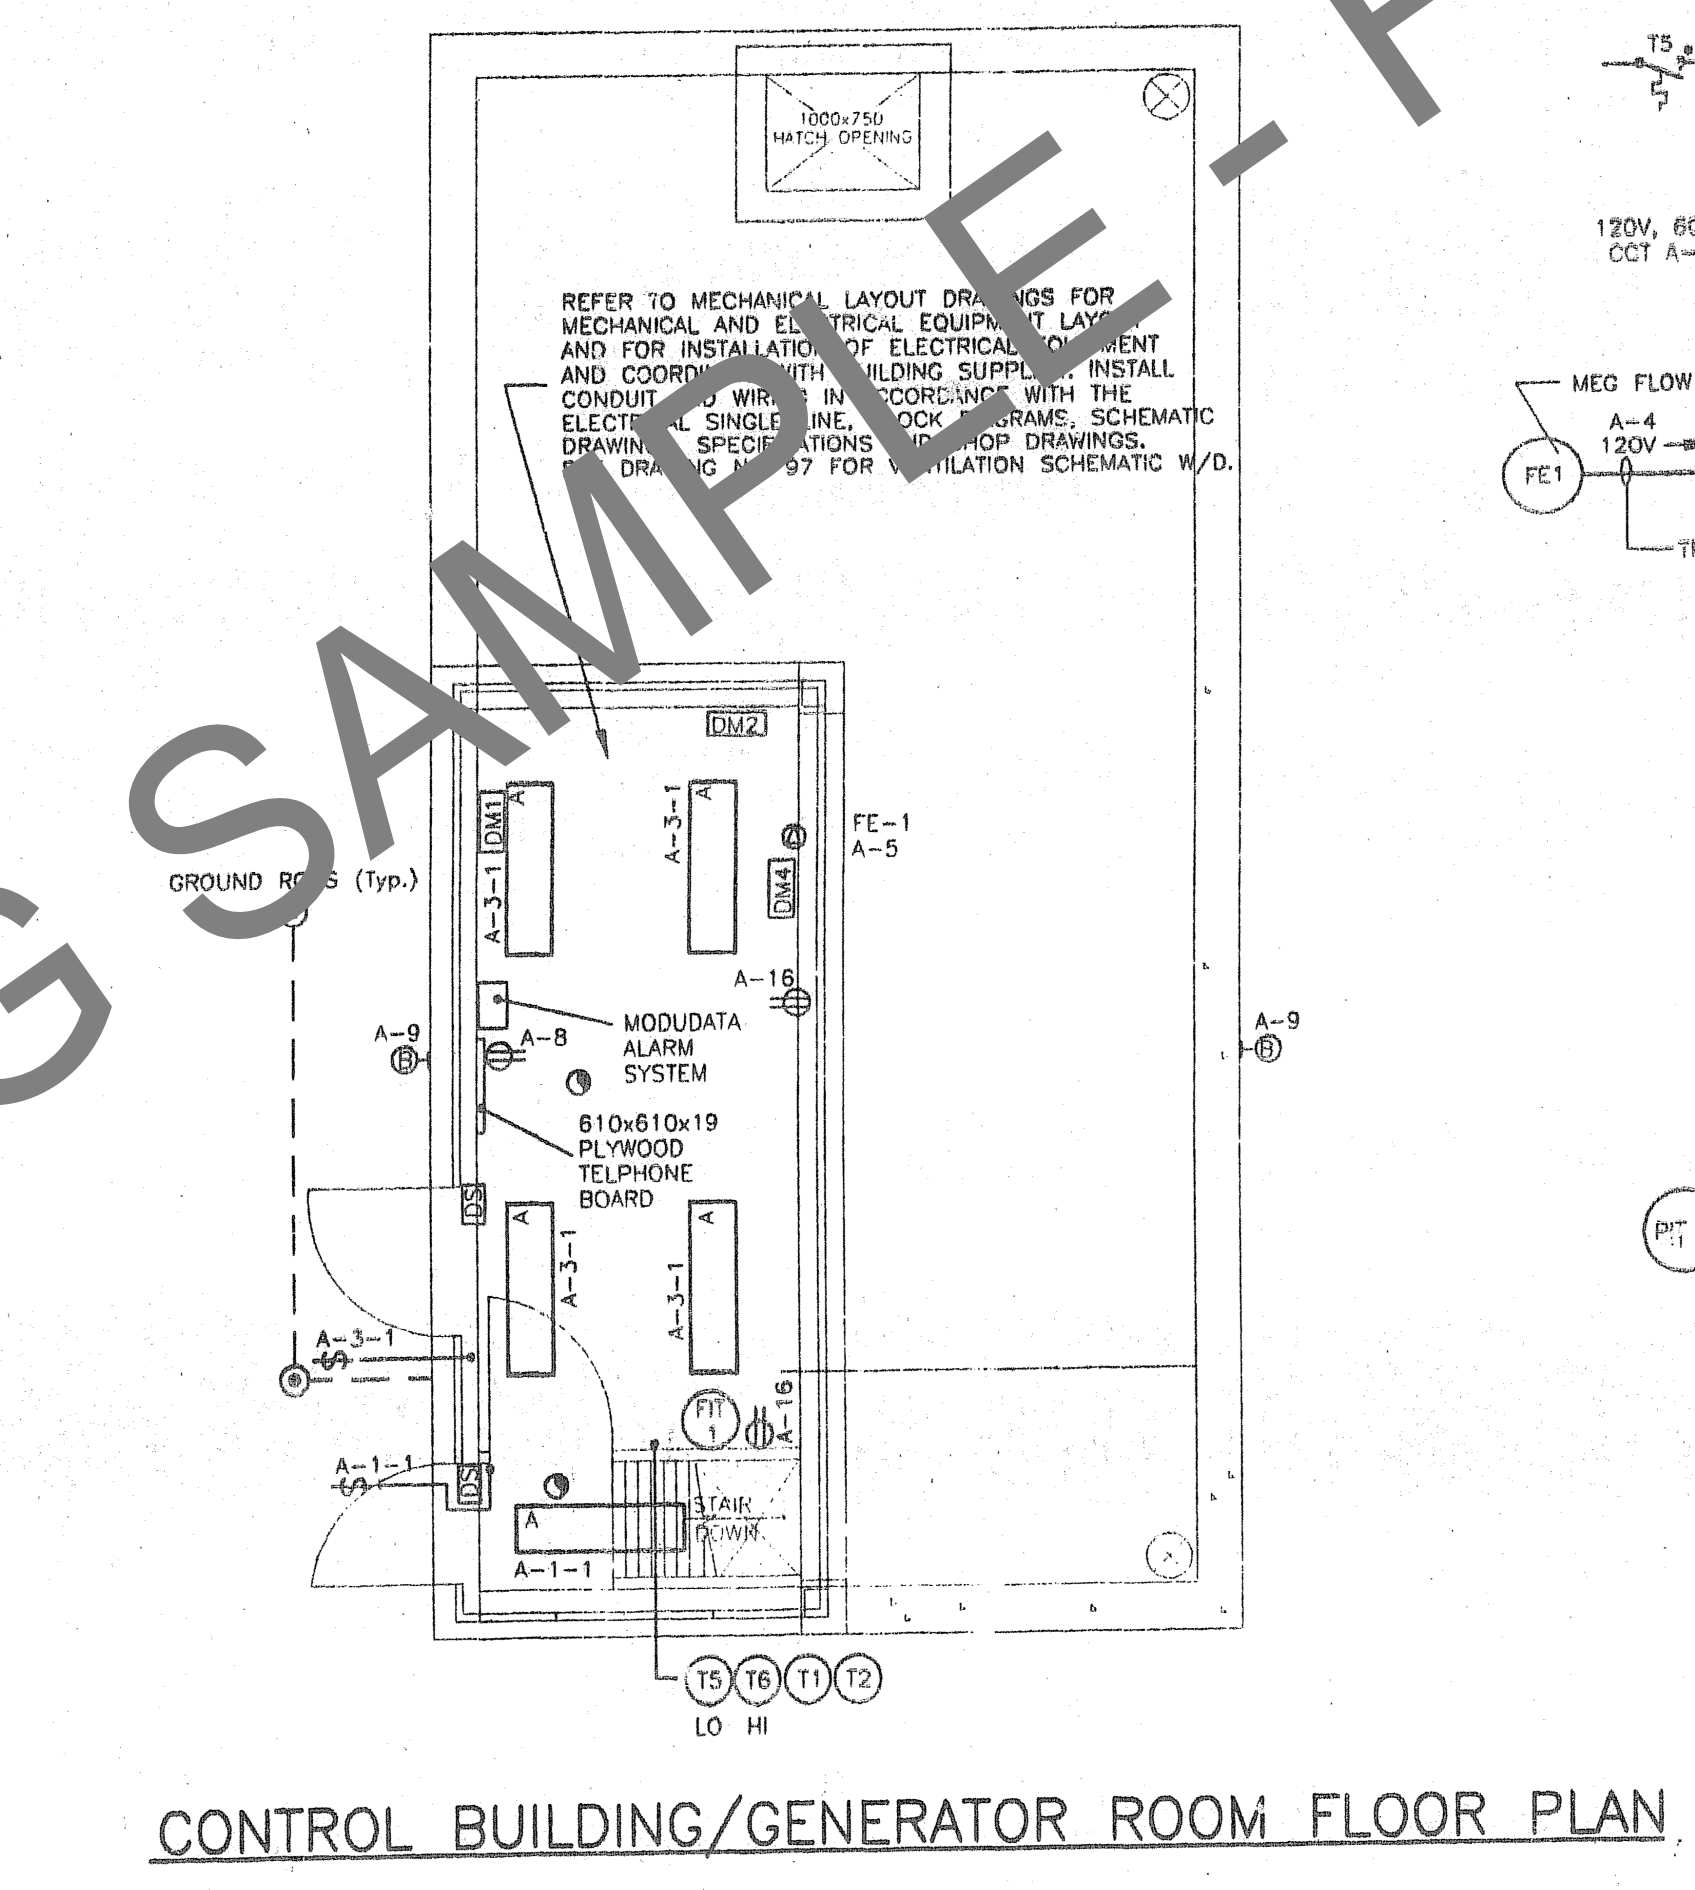
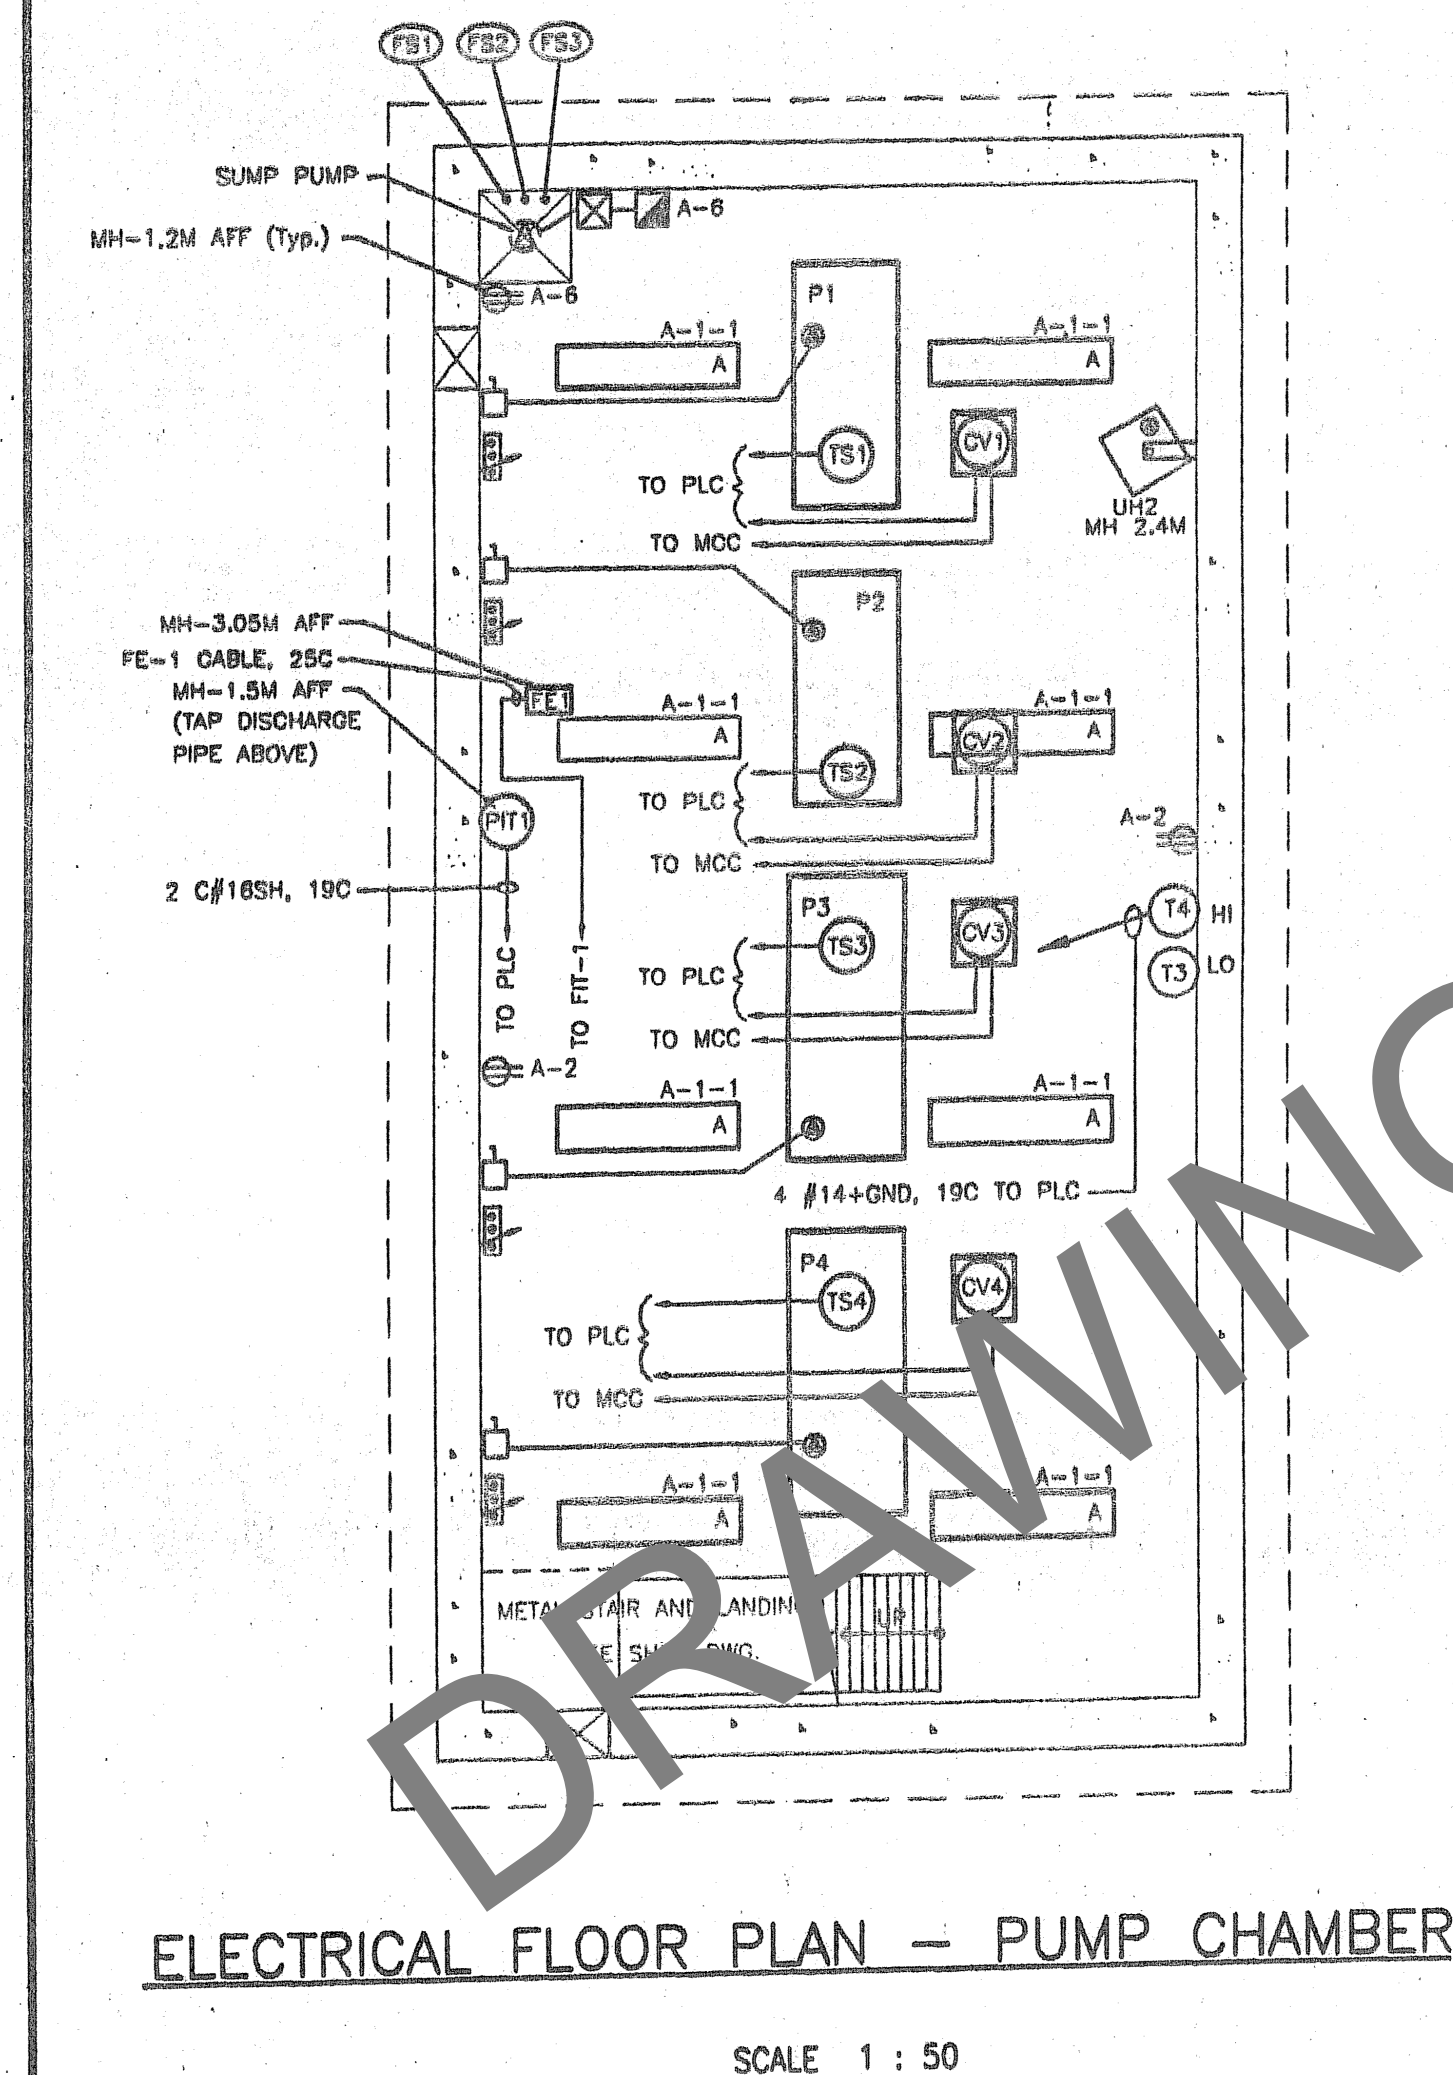
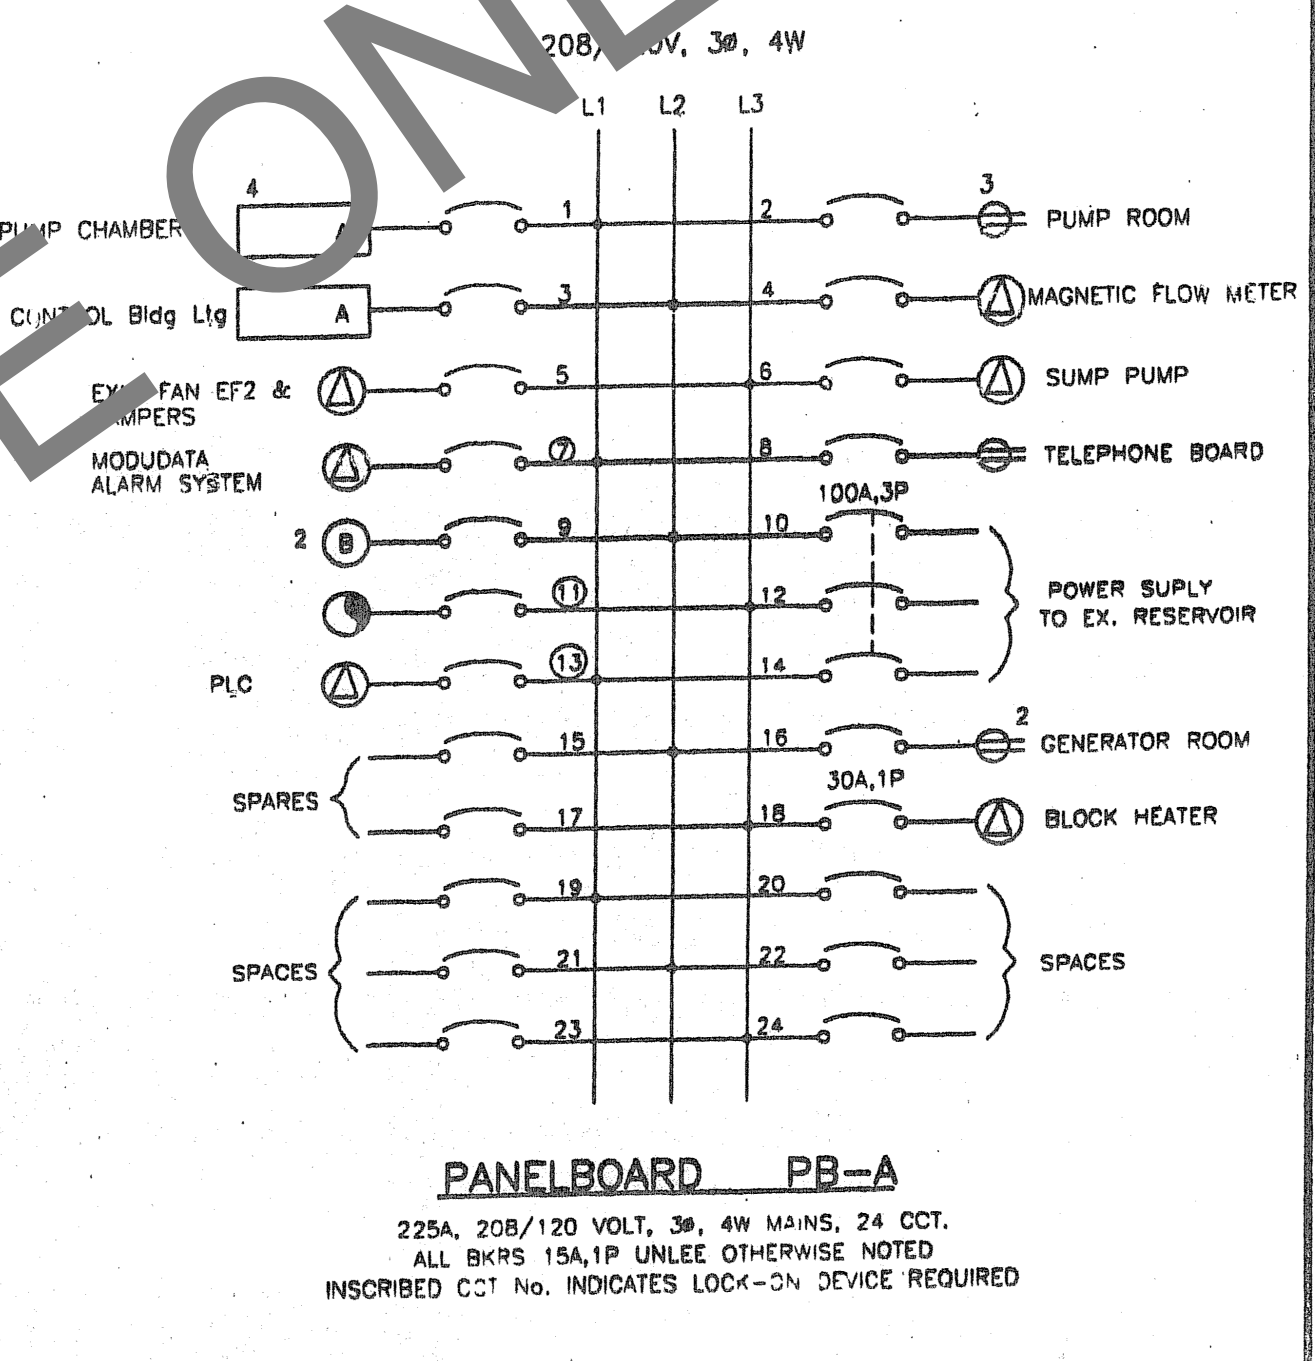
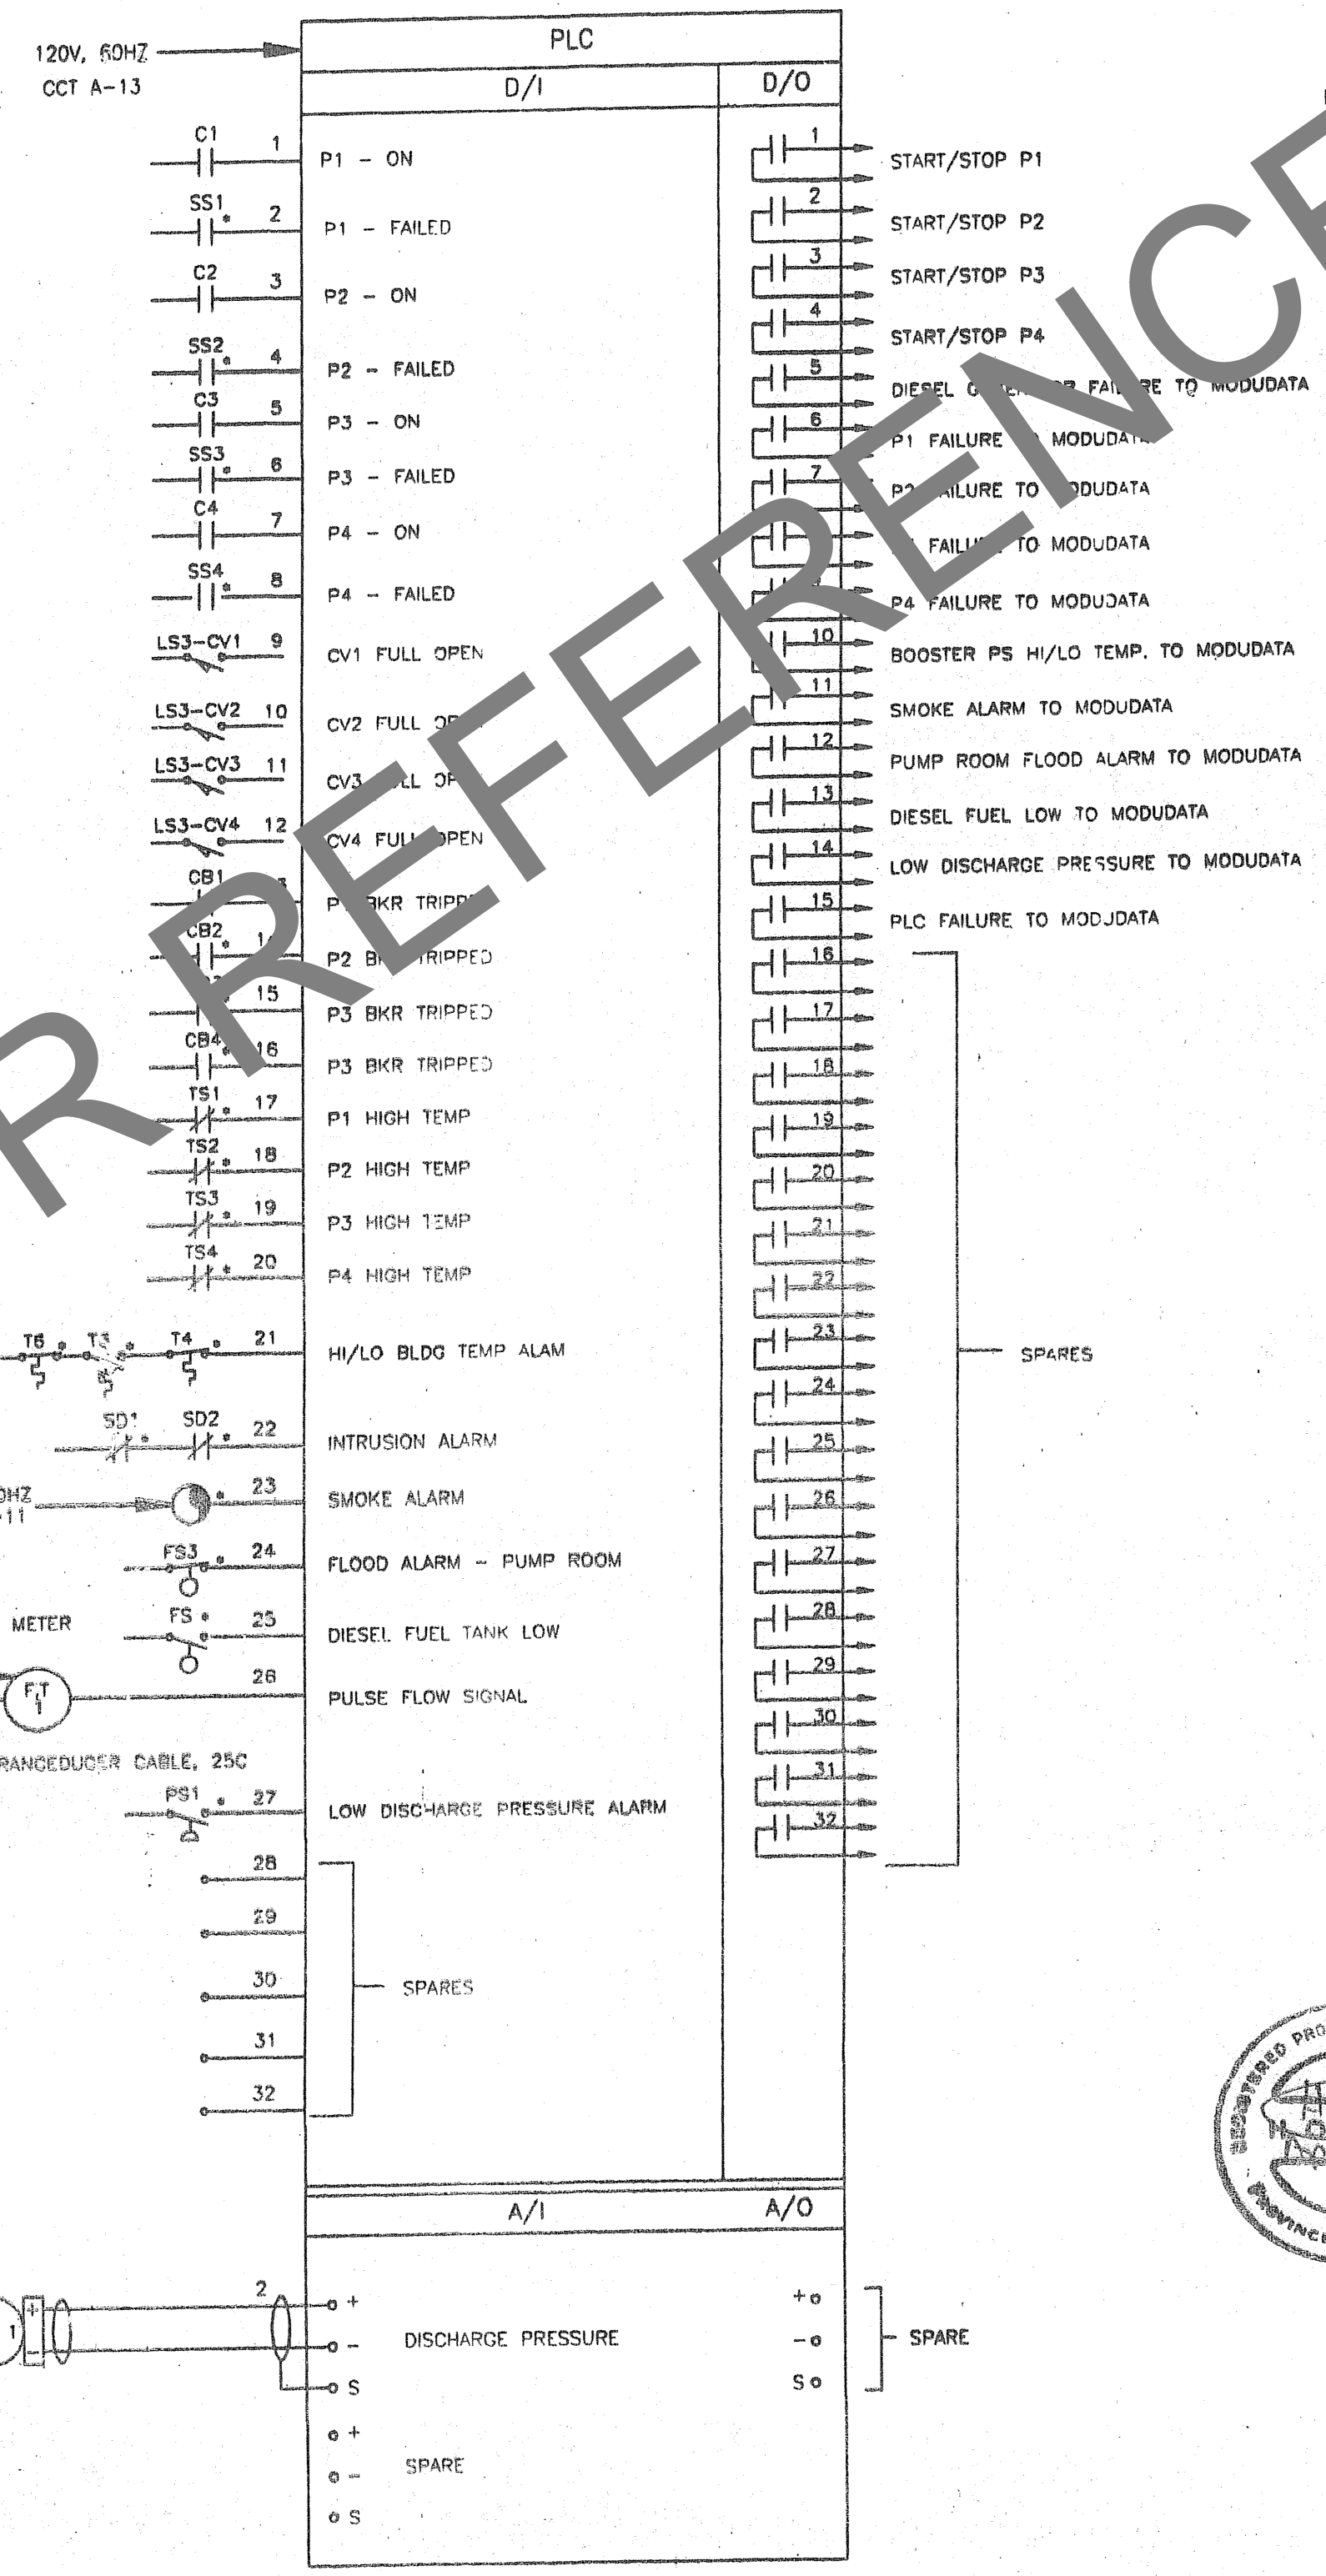
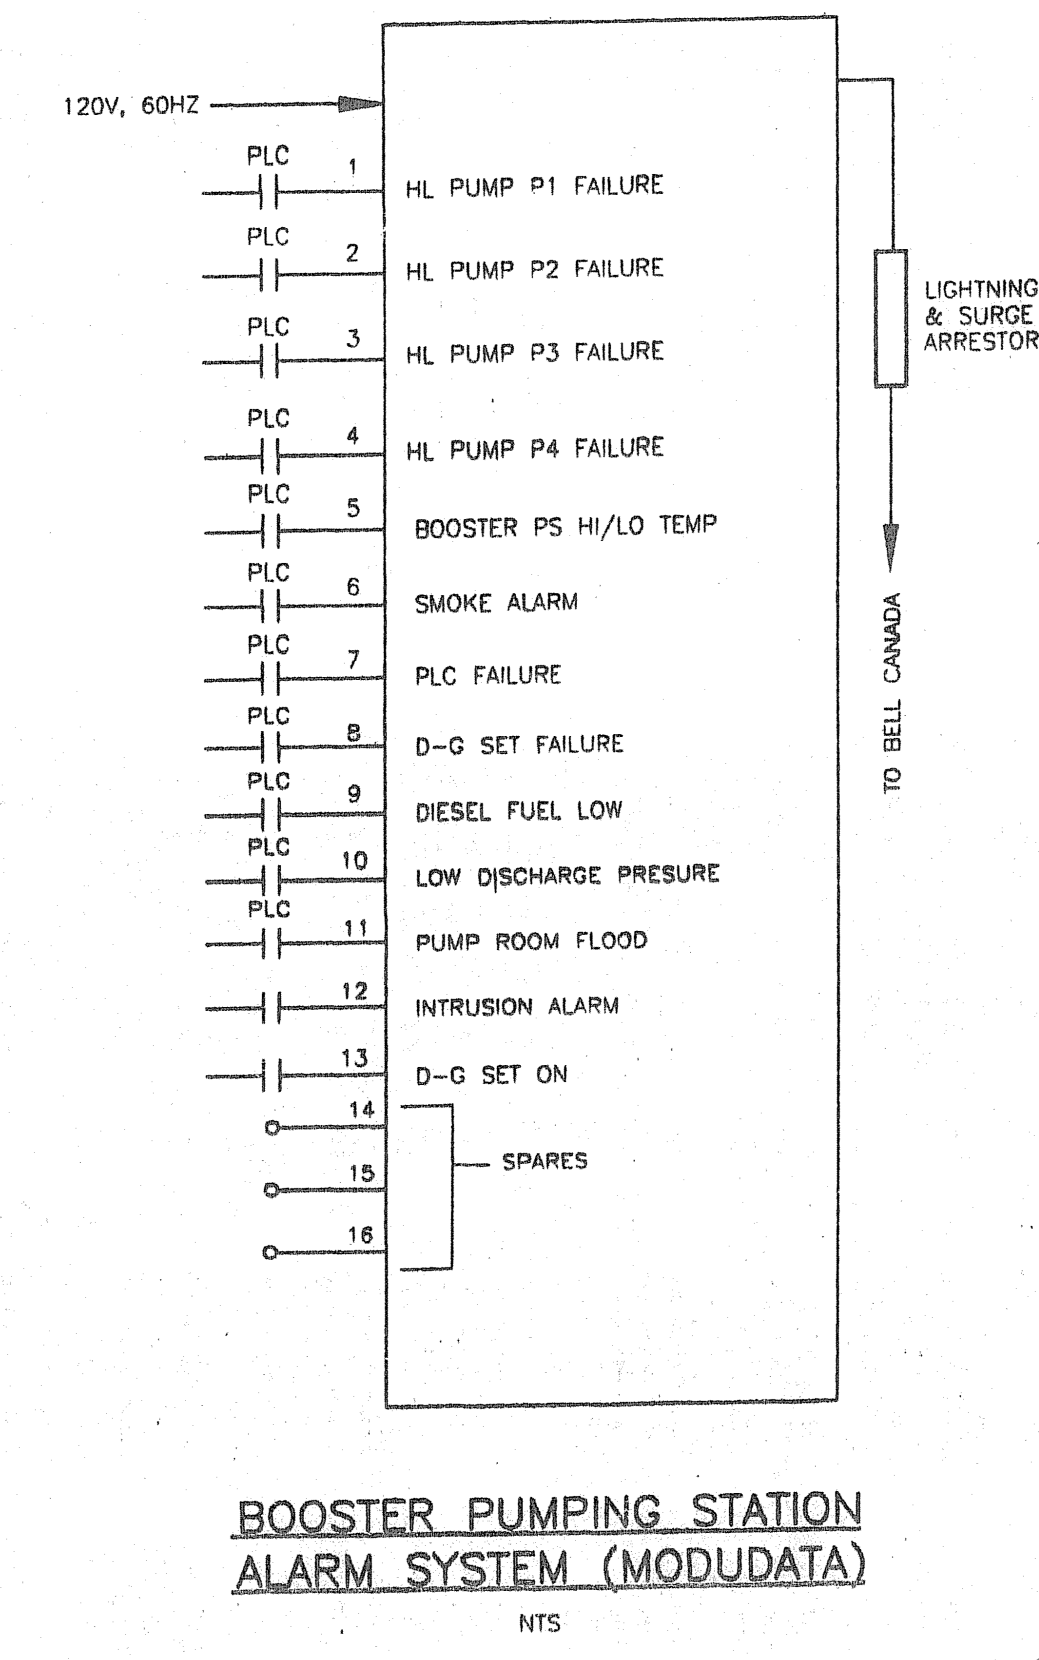


REVISIONS			
No.	DESCRIPTION	By	Date
1	REVISED REFERENCE TO DM 3	JDR	OCT 20/97

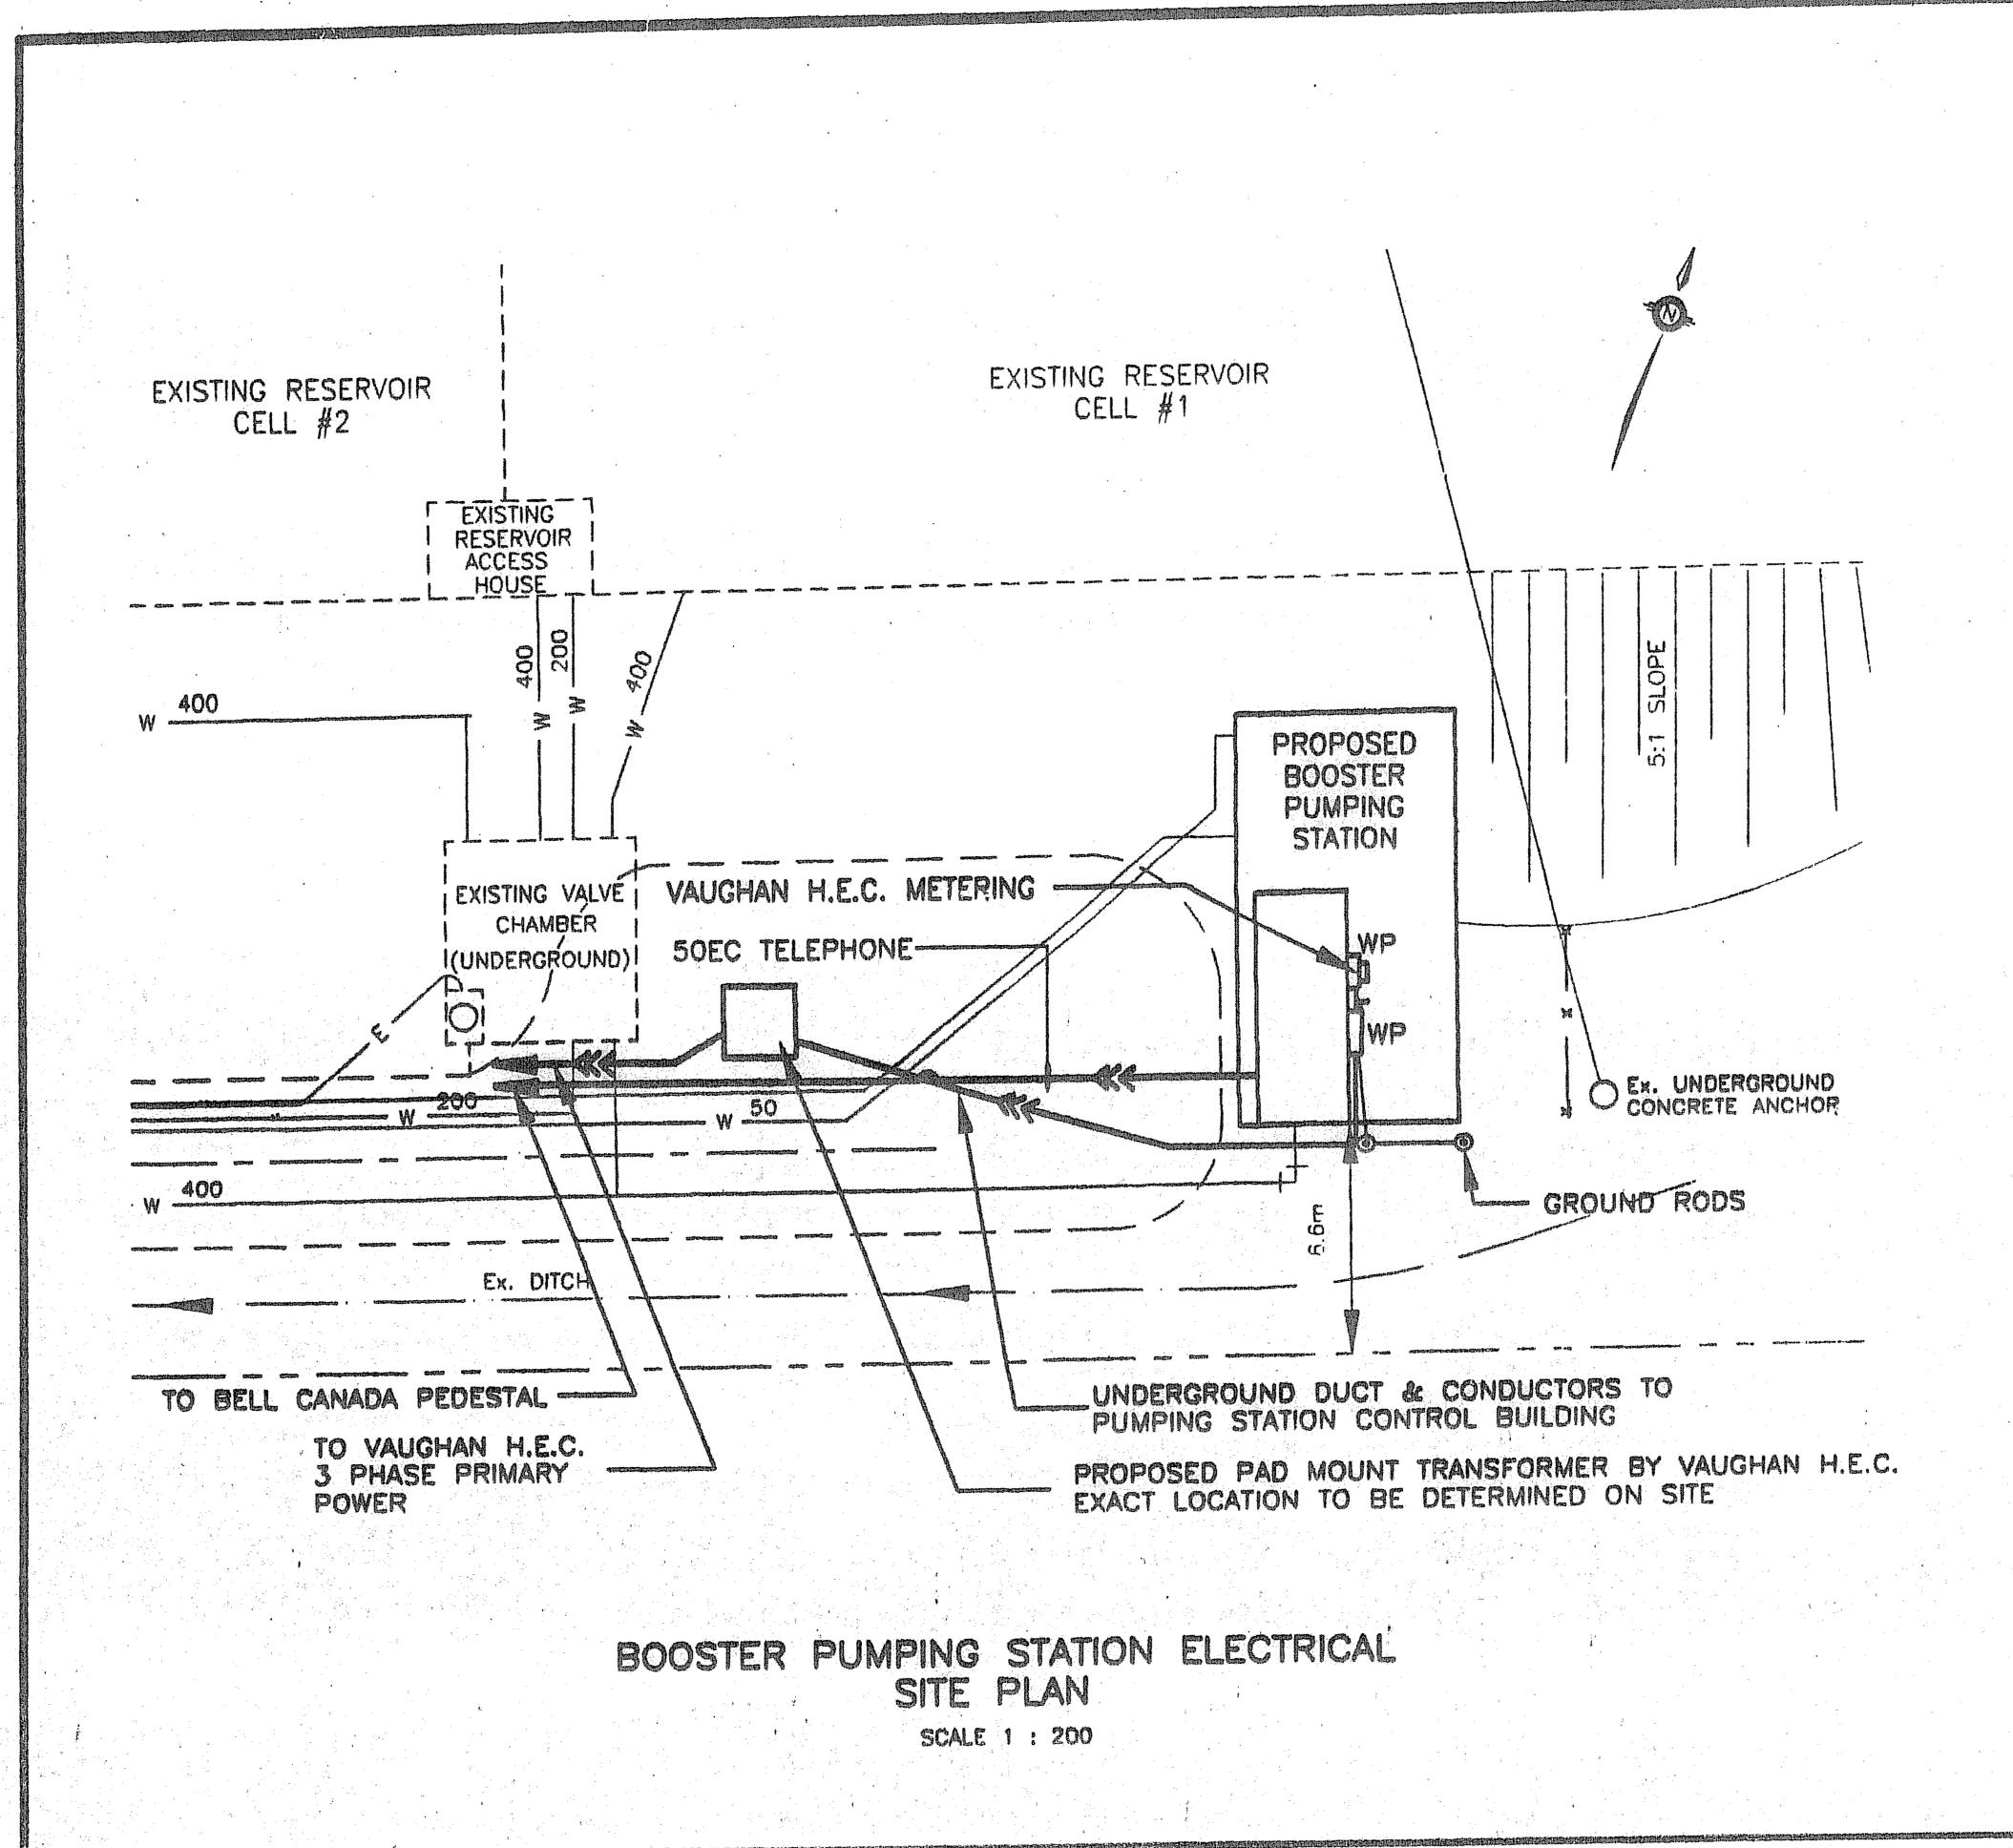

'AS CONSTRUCTED' SEPTEMBER 2002

COLE SHERMAN
LICENSED PROFESSIONAL ENGINEER
S. M. FORBES
PROVINCE OF ONTARIO

V. E. ROBINSON P. ENG. APRIL 8, 1998
DIRECTOR OF ENGINEERING DATE

SCHAEFFERS
Consulting Engineers
64 Jordin Drive
Concord, Ontario L4K 3P3
Tel: (905) 738-6100
Fax: (905) 738-6875
Toronto Line (416)213-5590

SCHAEFFER & ASSOCIATES LTD.

PROJECT No. 96-E-1894 DRAWING No. 16

SCALE: HORIZONTAL 0 400 1200 2000 2800 3600m

CITY OF VAUGHAN
ENGINEERING DEPARTMENT

NORTH MAPLE RESERVOIR BOOSTER PUMP STATION ELECTRICAL LAYOUTS AND DETAILS 19T-94023

DESIGNED BY: JAD	DATE:	CHECKED BY:
DRAWN BY:		APPROVED BY:
SCALE N.T.S.		DWG. No. P-

Plotted: Sun May 25 22:05:55 1997